

ISSUED FOR APPROVAL

KEY PLAN

GENERAL NOTES:

1. ALL DIMENSIONS ARE IN MM, UNLESS MENTIONED OTHERWISE.
2. ALL DIMENSIONS ARE ROUGH DIMENSIONS AND NOT FINISHED.
3. CONTRACTOR HAS TO PROVIDE ALL WATER SUPPLY AND SANITARY FIXTURE POINTS AT JUNCTION OF TILES ONLY AND TILES SELECTION AND PATTERN TO BE CONFIRMED BY ARCHITECT / INTERIOR DESIGNER.
4. CONTRACTOR HAS TO PROVIDE ALL WATER SUPPLY AND SANITARY POINTS ACCORDING TO THE FINAL MAKE AND MODEL SUGGESTED BY ARCHITECT / INTERIOR DESIGNER / CLIENT / ASPER OR BOQ.
5. ALL INCOMING PIPES IN TOILETS FROM EXTERNAL LINES TO BE PROVIDED BY ISOLATION COCK.
6. ANY AMBIGUITY FOUND SHALL BE BROUGHT TO CONSULTANT BEFORE COMMENCEMENT OF WORK.
7. ALL ISOLATION COCK TO BE PROVIDED AT 1.8 M. HEIGHT AT JUNCTION OF TILES.
8. ALL PIPE TRAVELING UP & DOWN TO BE TAKE ON MS ANGLE CLAMP.
9. WATER SUPPLY LINES SIZE AND DIMENSIONS WILL BE PROVIDED IN TILE PATTERN LAYOUT PROVIDED BY ARCHITECT.
10. ALL SOIL PIPES SHOULD BE GIVEN EVEN SLOPE OF 1:80.
11. ALL WASTE PIPES SHOULD BE GIVEN EVEN SLOPE OF 1:40.
12. ANY AMBIGUITY FOUND SHALL BE BROUGHT TO CONSULTANT BEFORE COMMENCEMENT OF WORK.
13. ALL SLEEVE, CUTOUT & SHAFT TO BE CONFIRMED AND APPROVED BY RESPECTIVE STRUCTURAL, CONSULTANT AND ARCHITECTS.

DESCRIPTION OF BUILDING:

Rev	Description	Date	Drawn	Checked
R2	AS PER ARCH. LAYOUT	23.12.16	SHIV	NILESH
R1	ISSUED FOR APPROVAL	22.12.16	SHIV	NILESH
RD	ISSUED FOR APPROVAL	22.12.16	SHIV	NILESH

REVISIONS / ISSUE

THIS DRAWING MUST NOT BE REPRODUCED IN WHOLE OR IN PART WITHOUT THE PRIOR APPROVAL OF Consultants

Client:

HIREN GANDHI

Architects

krti design

Structural

VIJAYBHAI MEHTA

MEP CONSULTANTS :-

ARTECH ENGINEERING SOLUTIONS
 Electrical & MEP, Engineering Design Consultant
 A-3, Dwar Paddartha, Opp. Vihar Bank
 Plot No. 19, Road No. 10/10
 Mohali-140404, Gurgaon
 www.artechng.com
 reg.artech@artechng.com
 Phone No. 075-2329117


PROJECT

ADALAJ TOILET BLOCK

Discipline: PLUMBING

Drawing title:
 INTERNAL PLUMBING LAYOUT OF EXISTING & NEW TOILET BLOCK (PLAN)

Project Ref No	Original Scale	Drawn	Checked	Authorised	Size
	1 : 100	NILESH	NILESH	AVNI	A3
		Date: 01.01.16	Date: 01.01.16	Date: 01.01.16	

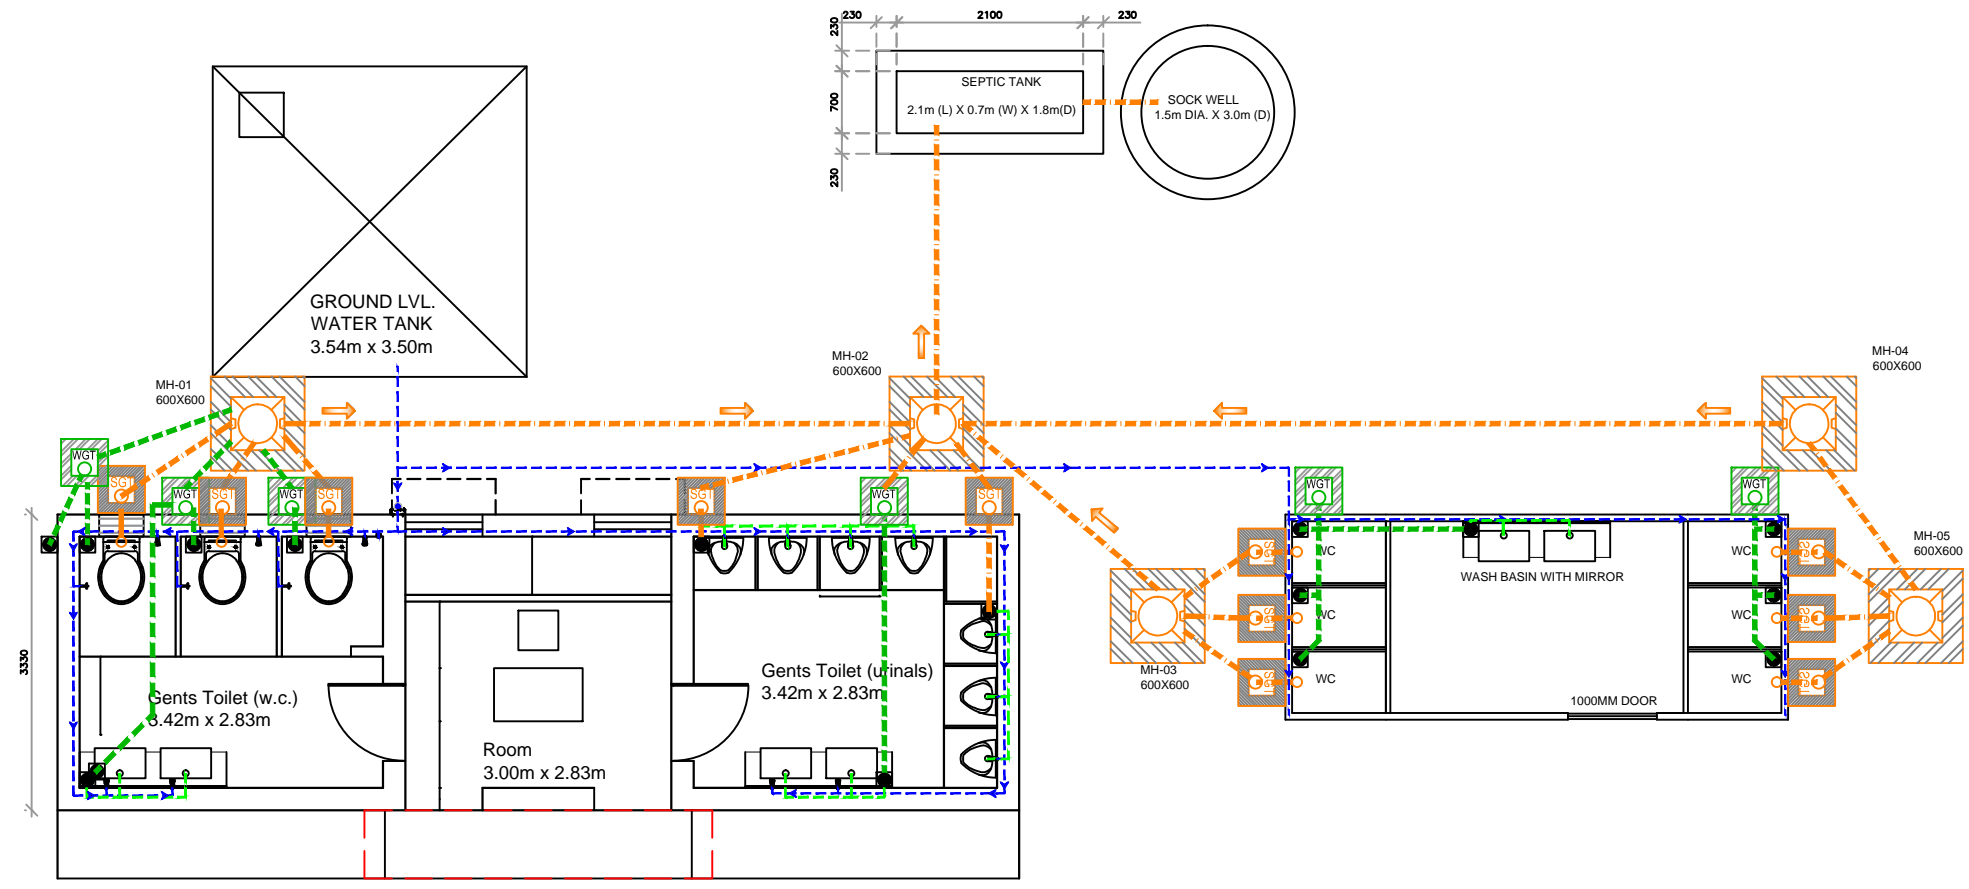

GENT'S TOILET (MODIFIED)

LADIES TOILET (STEEL CONTAINER TOILET)

LEGEND FOR PLUMBING FIXTURE:-

SYMBOL	DESCRIPTION		
	EUROPEAN WATER CLOSET FLOOR MOUNTING WITH 'S' TRAP		600X600X1L.DEEP SEWAGE MANHOLE
	WASH BASIN WITH BOTTLE TRAP		SEWAGE GULLY TRAP=SIZE, 300X300X700MM.
	URINAL WITH BOTTLE TRAP		WASTE WATER GULLY TRAP=SIZE, 300X300X(700/450) MM.
	NT MULTIFLOOR TRAP (4")		
	AC 150 ANGLE COCK (AC)		
	FT FLUSH TANK		
	CV CONTROL VALVE (STOP COCK)		
	HF HEALTH FAUCET WITH 2 WAY BIB COCK		

LEGEND FOR PIPE:-

SYMBOL	SPECIFICATIONS
	SWR PVC PIPE TYPE-B (6KG/CM2.) SOIL DOWNTAKE PIPE
	SWR PVC PIPE TYPE-B (6KG/CM2.) WASTE WATER DOWNTAKE PIPE
	SWR PVC PIPE TYPE-B (6KG/CM2.) RAIN WATER DOWNTAKE PIPE
	UPVC SCH 40 PIPE (COLD WATER)
	CPVC SDR 11 PIPE (HOT WATER)
	PLUMBING WALL